



Bundled Liquid Fuel storage tanks and bund Total 100,000 litres

Fuel Tank 12.5m Long by 3.0m Wide by 3.3m High

4 No. Gas Tanks - 13.0m Long by 3.5m wide by 4.0m High

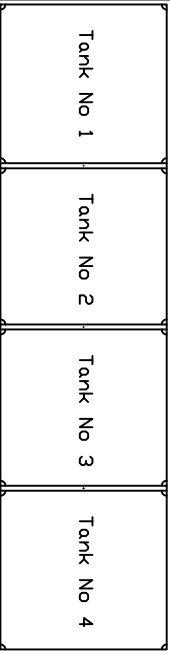

Optional Gas Compression Unit - 8.0m Long by 3.1m wide by 3.1m High

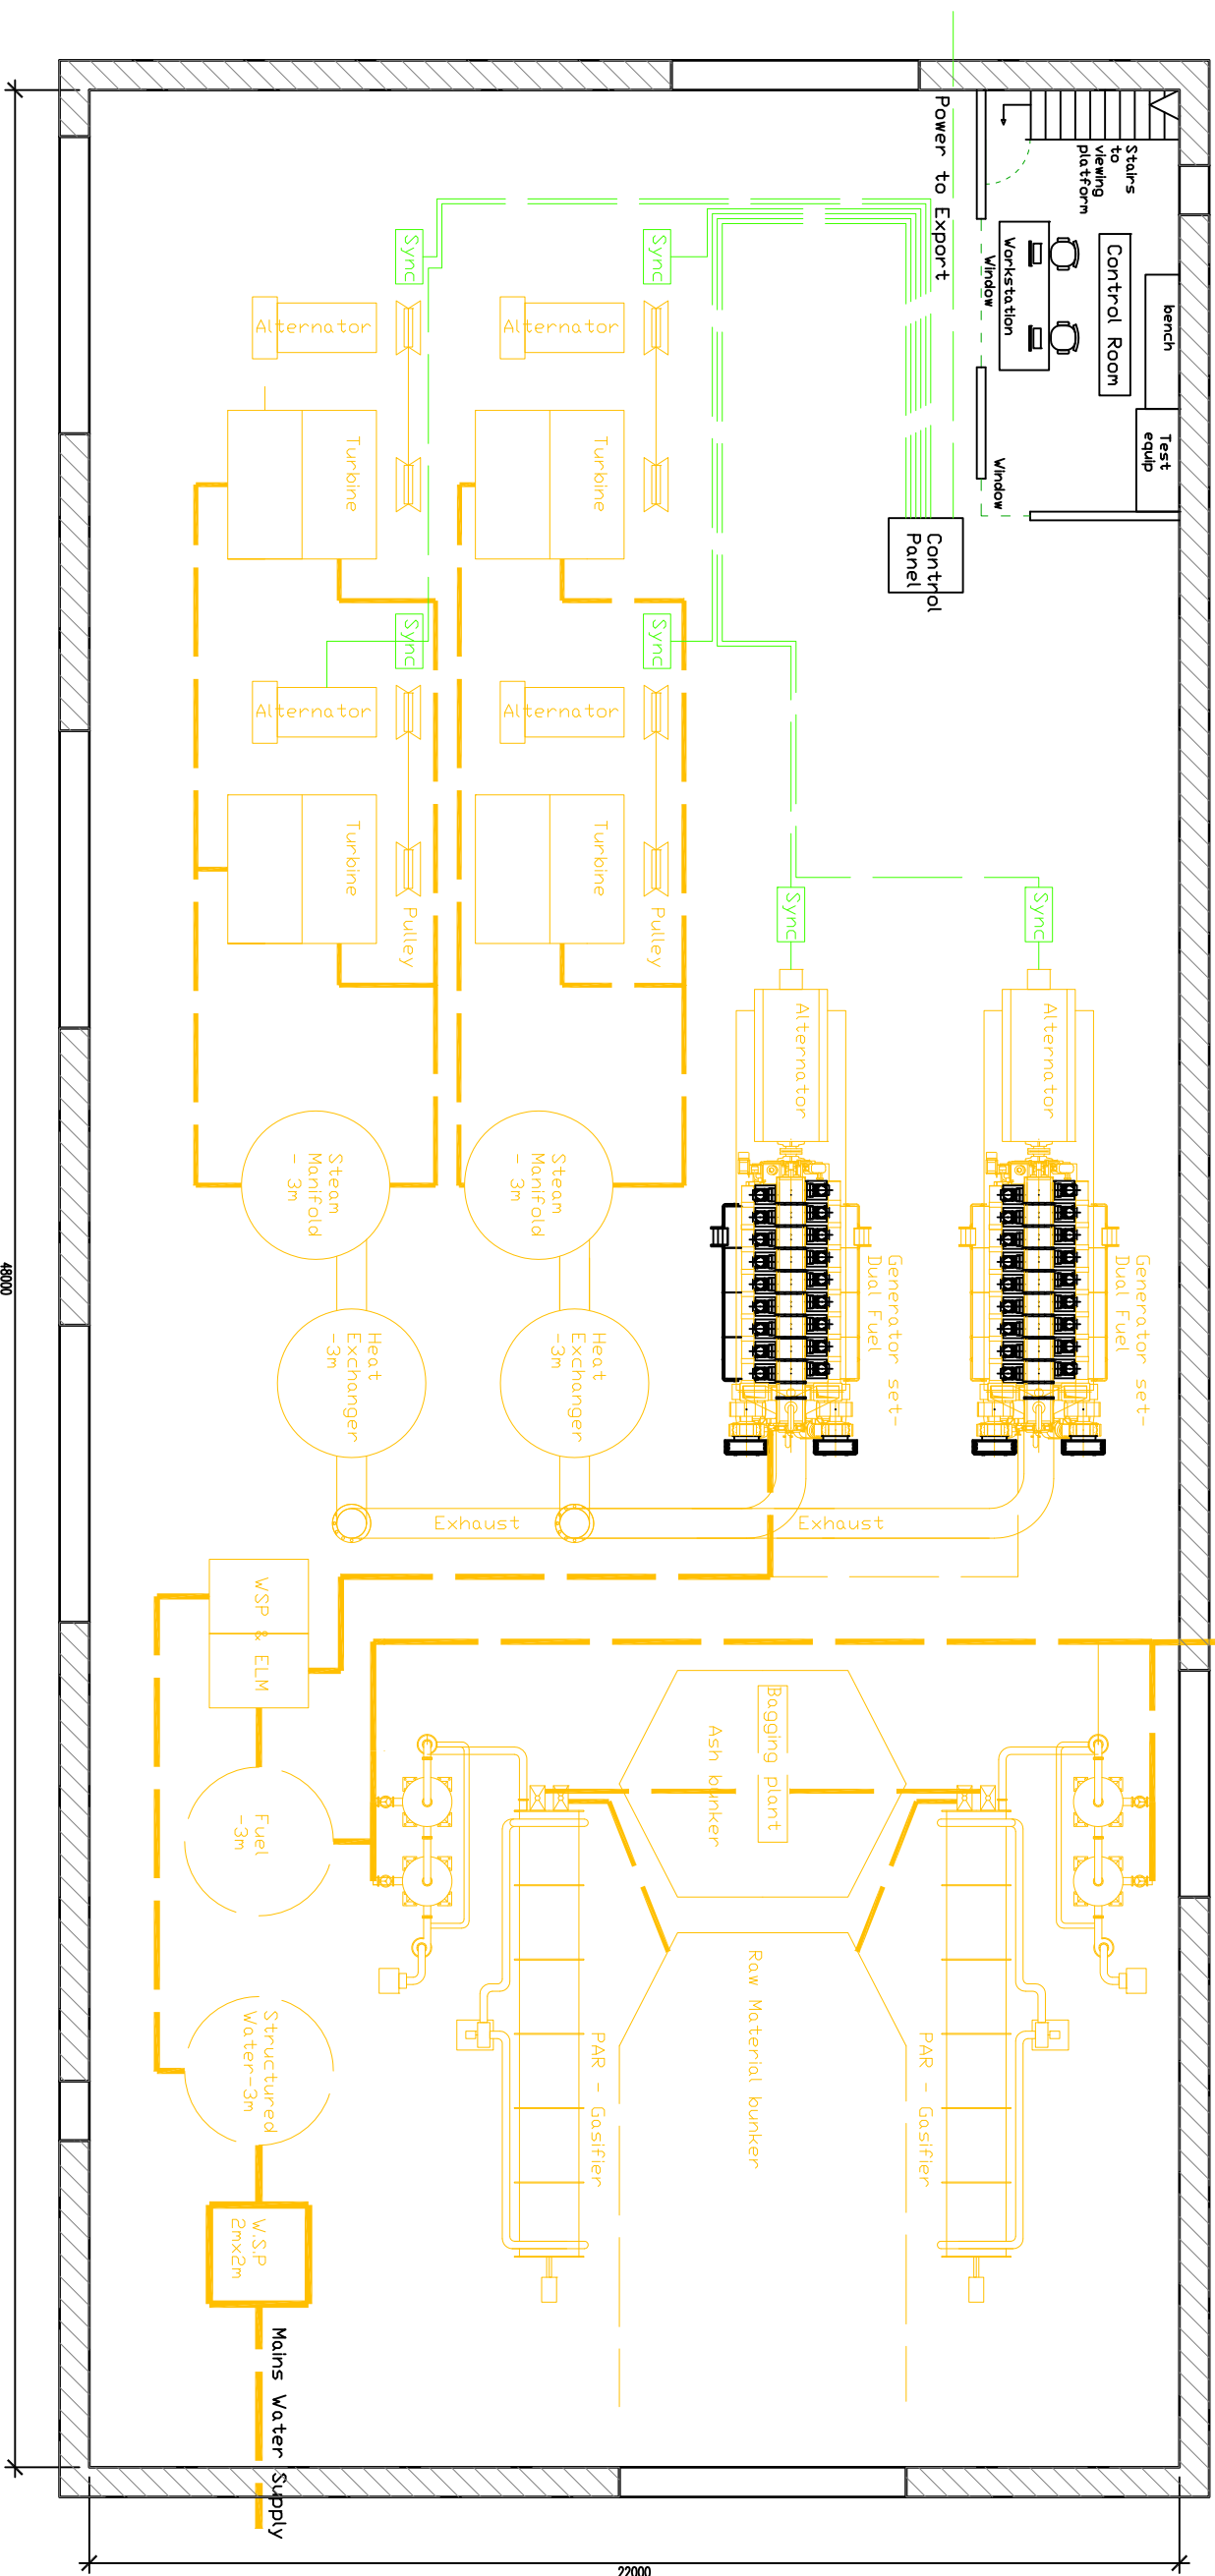

6MW PLANT - 2 PARS & 2 GEN SET
WITH HEAT RECOVERY &
40% LIQUID FUEL REDUCTION

Rev.	Date	By	Revision
A	01/07/15	DJL	FOR INFORMATION

ODJCO Consulting Engineers LTD
This drawing and any design hereon is the copyright of the consultants and must not be reproduced without their written consent. The consultants accept no responsibility for the design or construction of any plant or equipment shown on this drawing. Consultants to be informed immediately of any discrepancies before work proceeds.

Client
PHI

Project
Project Alpha

Dwg Title
PRELIM 6MW & 40%FR & HR Power Plant Layout

NOTES

ODJCO CONSULTING ENGINEERS.
THE HERITAGE WORKROOM Co. CO. KK.
Tel: (086) 3899776
email: djco@odjco.ie

Drawn By	DJL	Scale	1/150
Checked By	DJL	Date	23/06/2015
Dwg.No.	L175-012	Rev.	A